





 
 
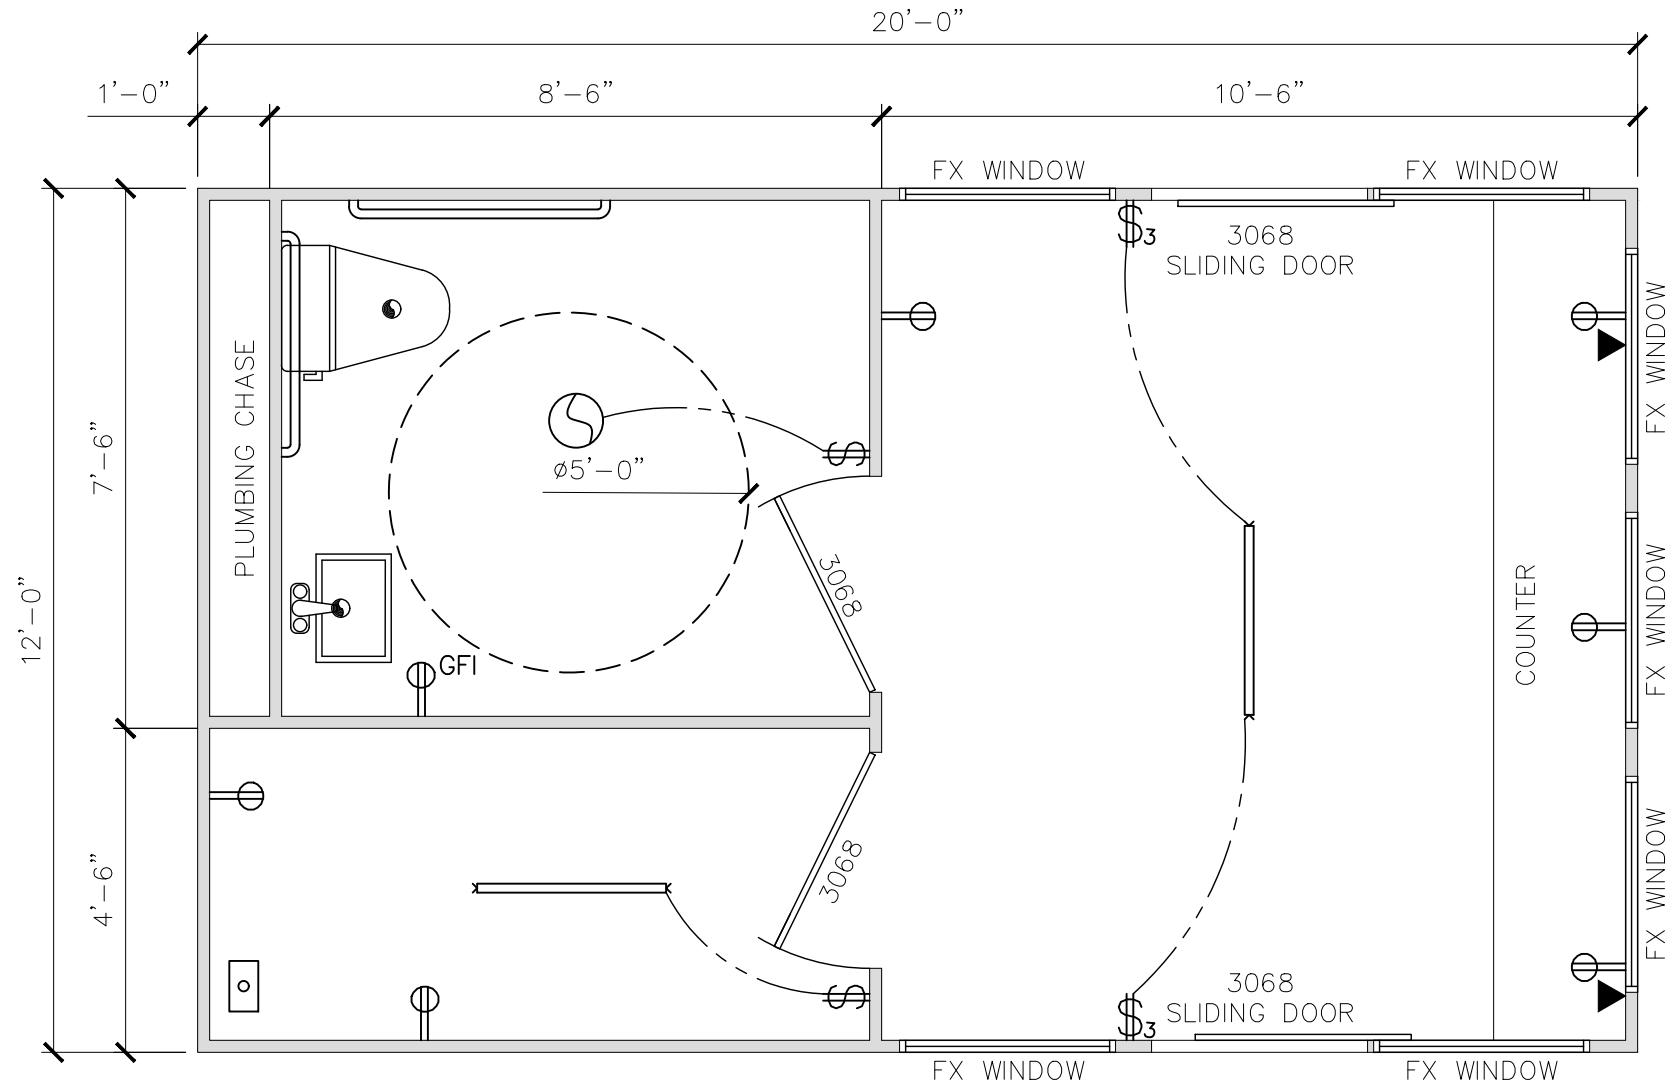


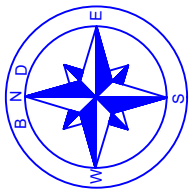
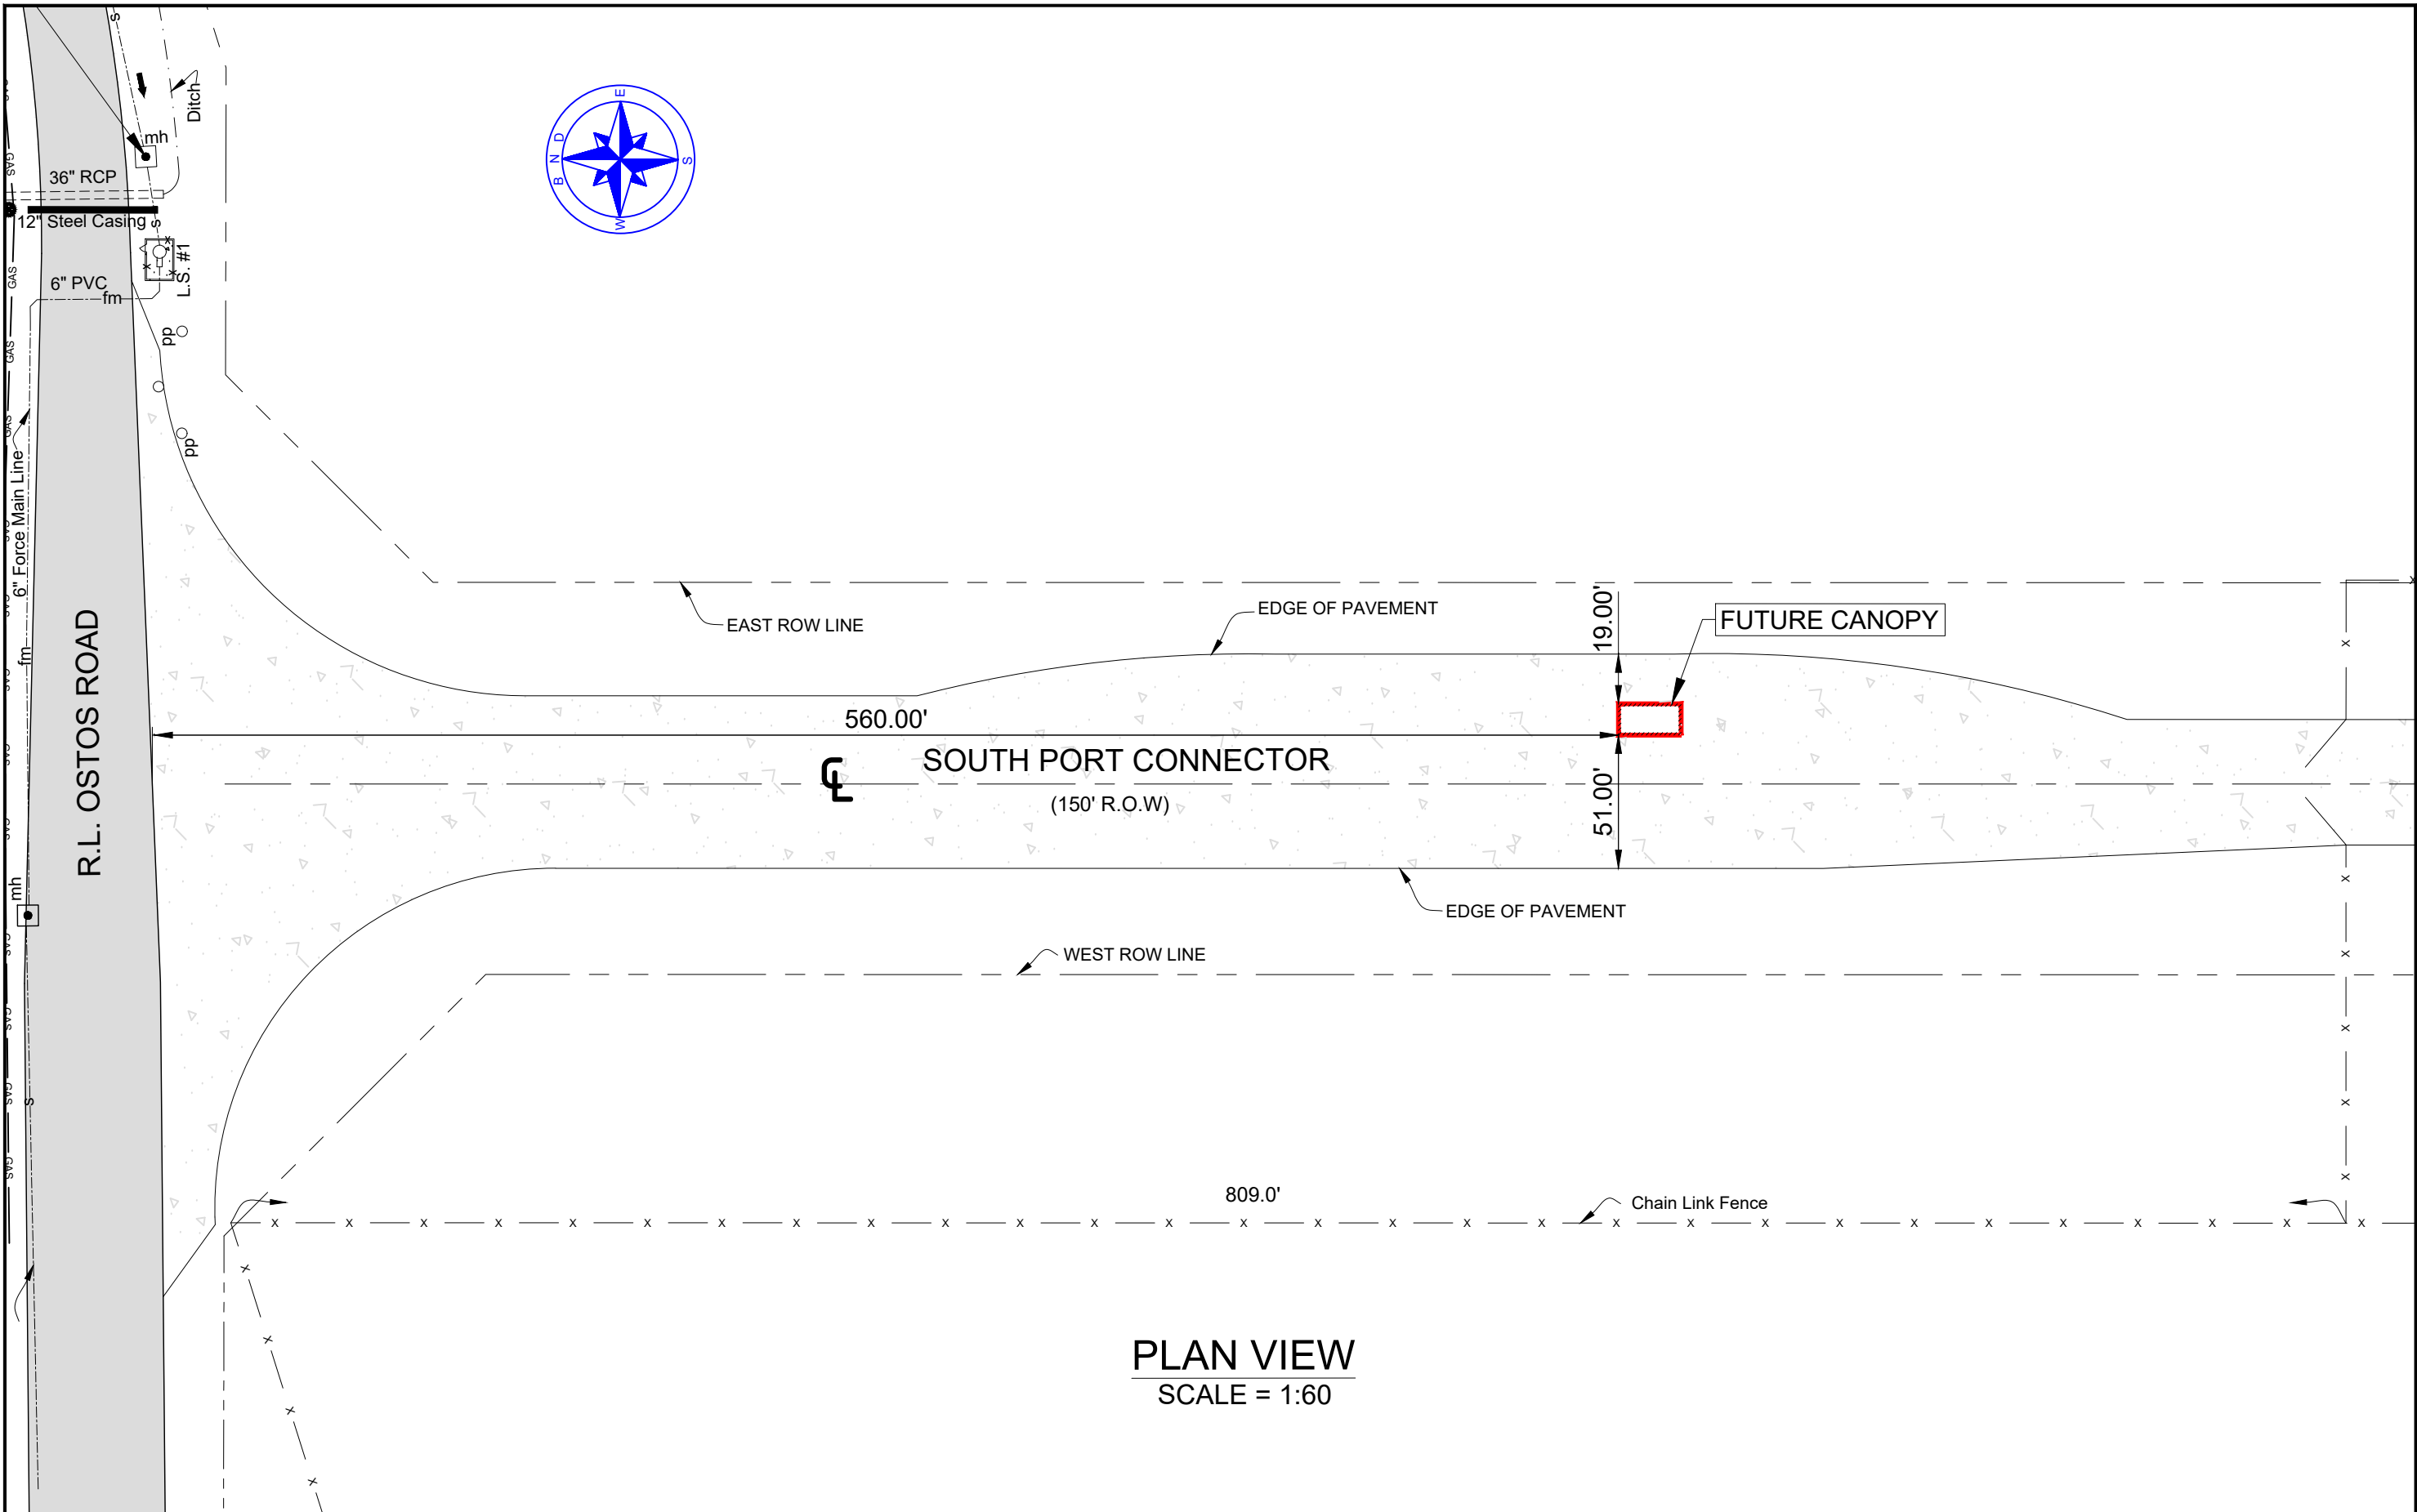
SYMBOLS LEGEND

-  DUPLEX OUTLET
-  GFI
-  PHONE AND DATA PORT
-  SINGLE POLE SWITCH
-  THREE WAY SWITCH
-  EXHAUST FAN/LIGHT
-  FLOURESCENT LIGHT FIXTURE
-  LOAD CENTER



FLOOR PLAN
SCALE: 3/8" = 1'-0"

APPROVED BY:	REVISION DATE:
DATE DRAWN: 11/1/21	DWG. NO.
CHECKED BY:	FILE NAME: Z:\David\Port\DurAluminum.dwg
SCALE: AS SHOWN	



PLAN VIEW
SCALE = 1:60

**SOUTH PORT CONNECTOR ROAD
ENTRANCE SECURITY GUARDHOUSE**

APPROVED BY: DE	REVISION DATE: 11/1/21	DWG. NO.	FILE NAME: Z:\David\Port Duratium.dwg
DATE DRAWN: 11/1/21	CHECKED BY:	SCALE: AS SHOWN	

BROWNSVILLE NAVIGATION DISTRICT
ENGINEERING DEPARTMENT
BROWNSVILLE, TEXAS 78521
PHONE (956) 831-4592 1-800-378-5395
FAX (956) 831-6153
EMAIL achavez@portofbrownsville.com